

DRWN	R	A	J	I	V
CHKD	B	N	K		

PROJECT:

RESIDENTIAL INTERIORS

LOCATION:

SADAPUR, LONAVALA

CLIENT:

ARCON'S  
INFRASTRUCTURE

ARCHITECT & PLANNERS:

think BNK

 
JOB NO. SDR-LNVL-01

DWG. TITLE GROUND FLOOR PLAN

DWG. NO.

DATE: 27/04/11

NORTH



SCALE N.T.S.

REVISION R1

DATE DESCRIPTION

APPROVAL DWG


ARCHITECT'S STAMP & SIGNATURE

CLIENT'S STAMP & SIGNATURE

Architect  
**BNK**  
Behzad  
Noshir  
Kharas

134/135, 1st FLOOR, THE BAYSIDE MALL,  
HAJI ALI, TARDEO, MUMBAI-400034,  
PH. +91-022-66100313 / FAX. 66100314

111, DESAI BUNGLAW, 1ST FLOOR,  
COLLEGE ROAD, NASHIK-5  
VOICE: 09890269916

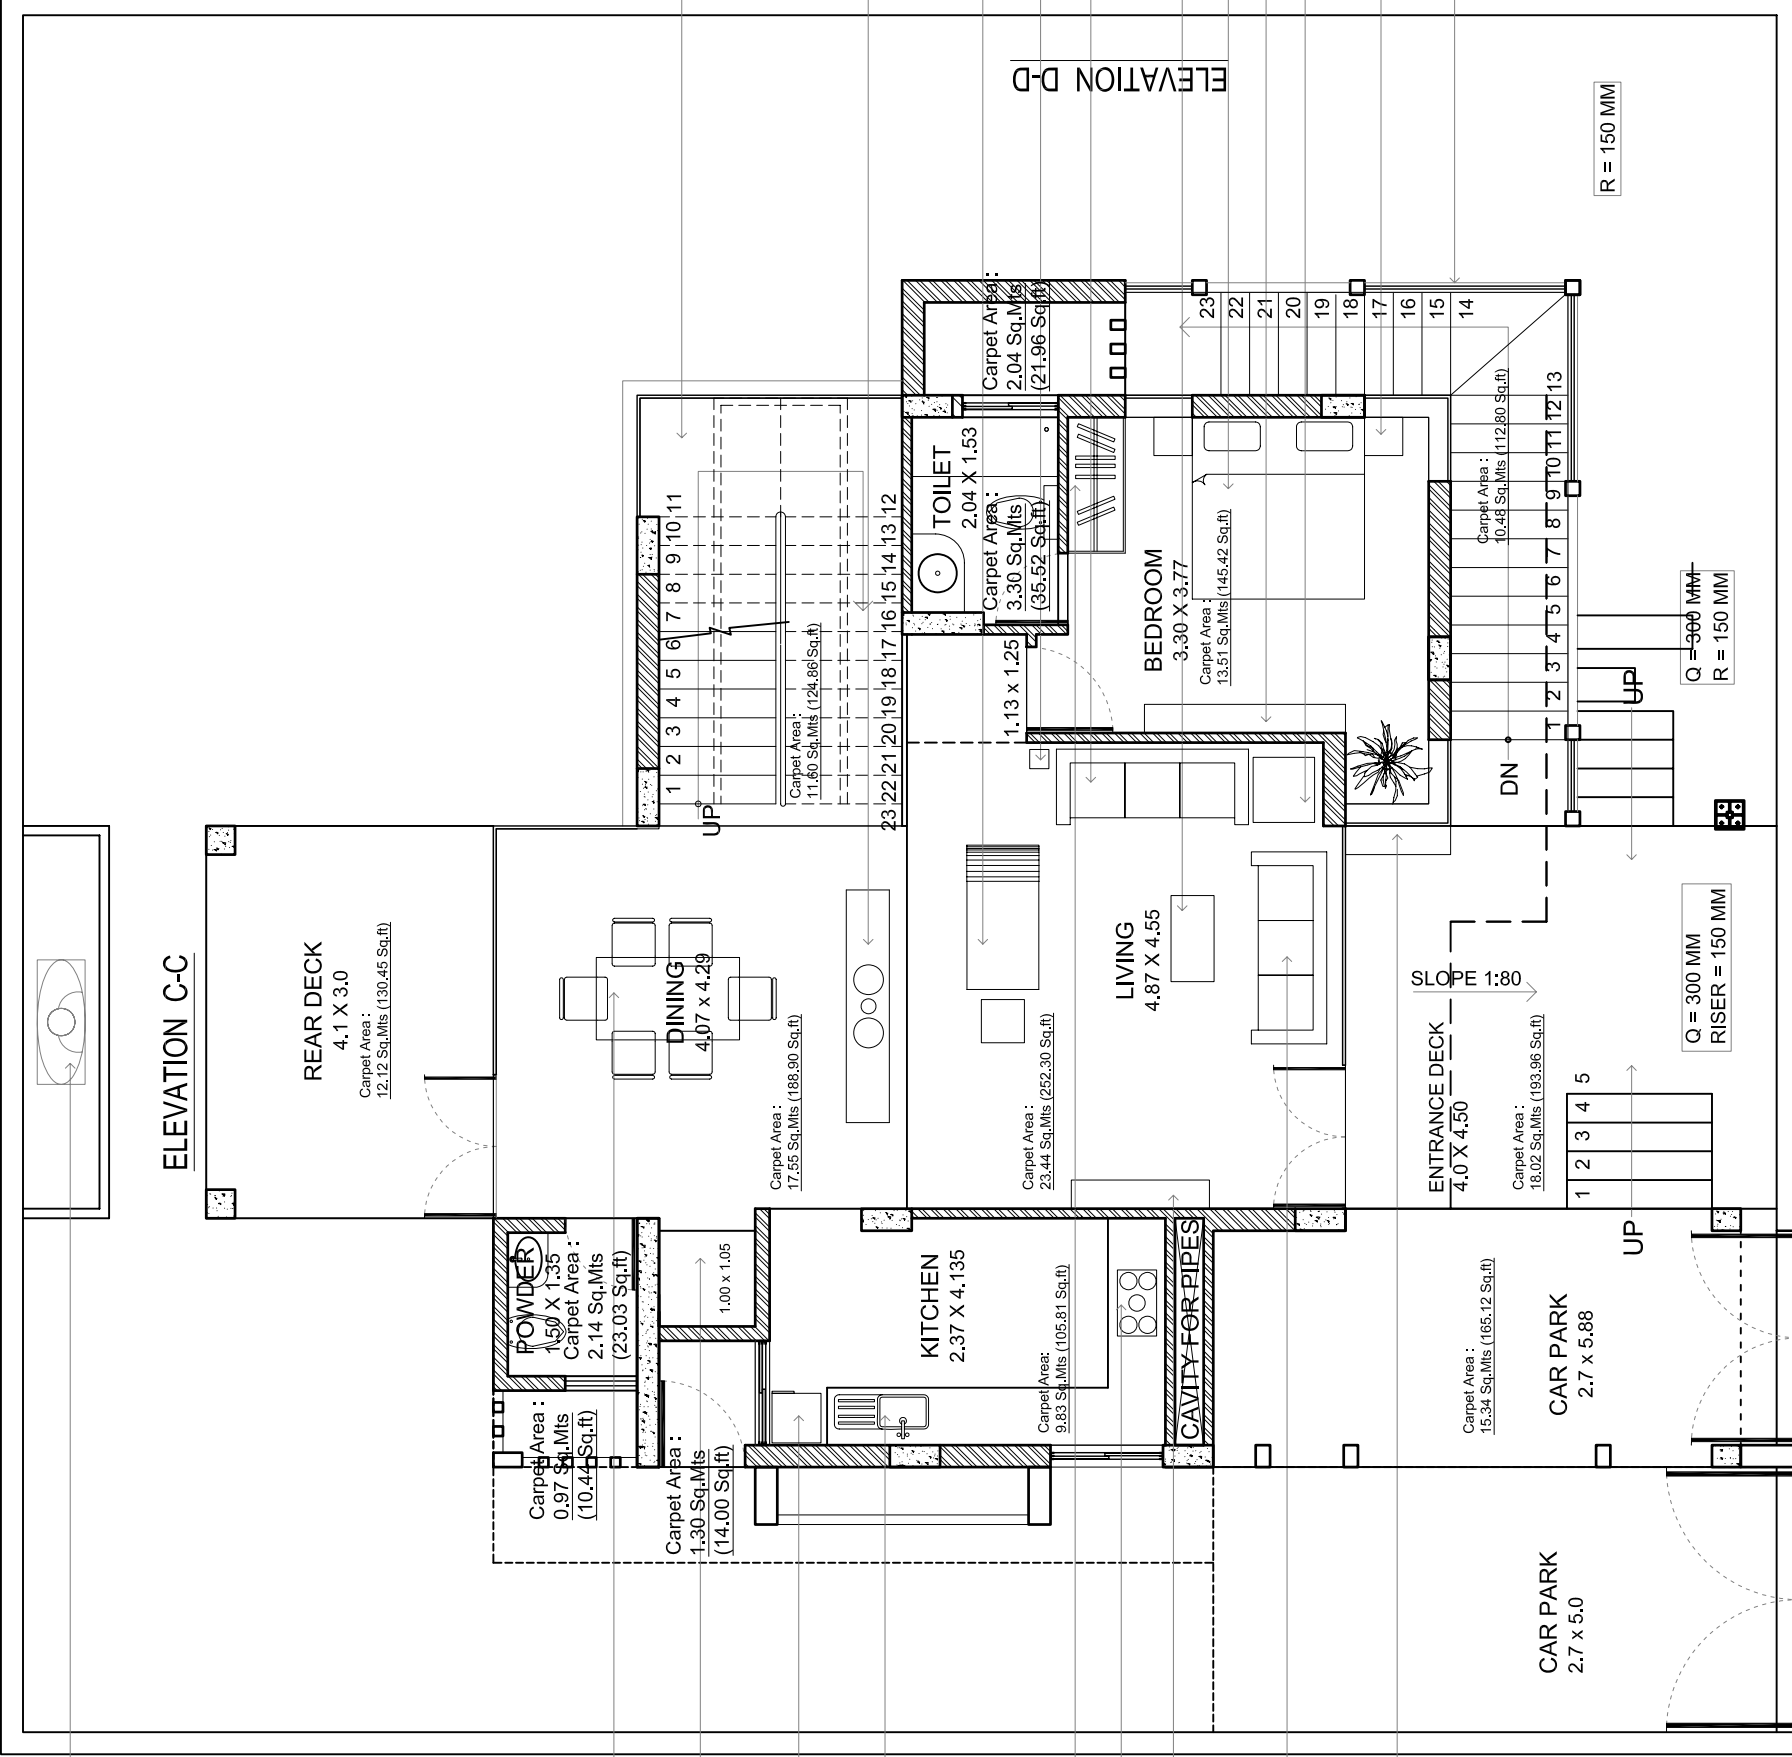

STATUE

6-SEATER DINING TABLE

LIFT AREA

FRIDGE (360 Ltrs)

STAINLESS STEEL  
SINK

4'6" x 7'0" WARDROBE

HOB FABER MAKE

LCD UNIT

3-SEATER SOFA

SHOE RACK

ELEVATION C-C

ELEVATION D-D

ELEVATION B-B

M.S. STAIRCASE

4'0" HIGH LIBRARY RACK WITH  
ARTIFACTS ABOVE

RECLINER CHAIR

FLOOR LAMP

3-SEATER SOFA

CENTRE TABLE

QUEEN SIZE BED

LCD UNIT WITH GLASS SHELVES  
SIDE TABLE

2 Nos. NIGHT STAND

GLASS IN FRONT OF  
WINDOWS

R = 150 MM

Q = 300 MM  
R = 150 MM

Q = 300 MM  
RISER = 150 MM